


DRAWING NOTES:

- ① PROVIDE NEW EXTERIOR, TYPE AS INDICATED. C/W ALL CONDUIT, WIRING, POLE AND ASSOCIATED HARDWARE. ALL EXTERIOR LIGHTING TO BE CONTROLLED BY COMMON PHOTOCELL. ALL POLE LIGHTING TO BE FED FROM GARAGE BUILDING.
- ② PROVIDE NEW ELECTRICAL FEED FROM EXISTING GARAGE TO NEW ADMIN BUILDING. PROVIDE NEW COMMUNICATION CONDUIT AS INDICATED. REFER TO FLOOR PLAN FOR FURTHER DETAILS.
- ③ PROVIDE NEW 120V 20A DIRECT CONNECTION TO NEW POWER GATE. COORDINATE EXACT CONNECTIONS ON SITE. TO BE FED FROM GARAGE BUILDING. C/W ALL CONDUIT AND WIRING. PROVIDE 2 X 25MMC TO GATE.

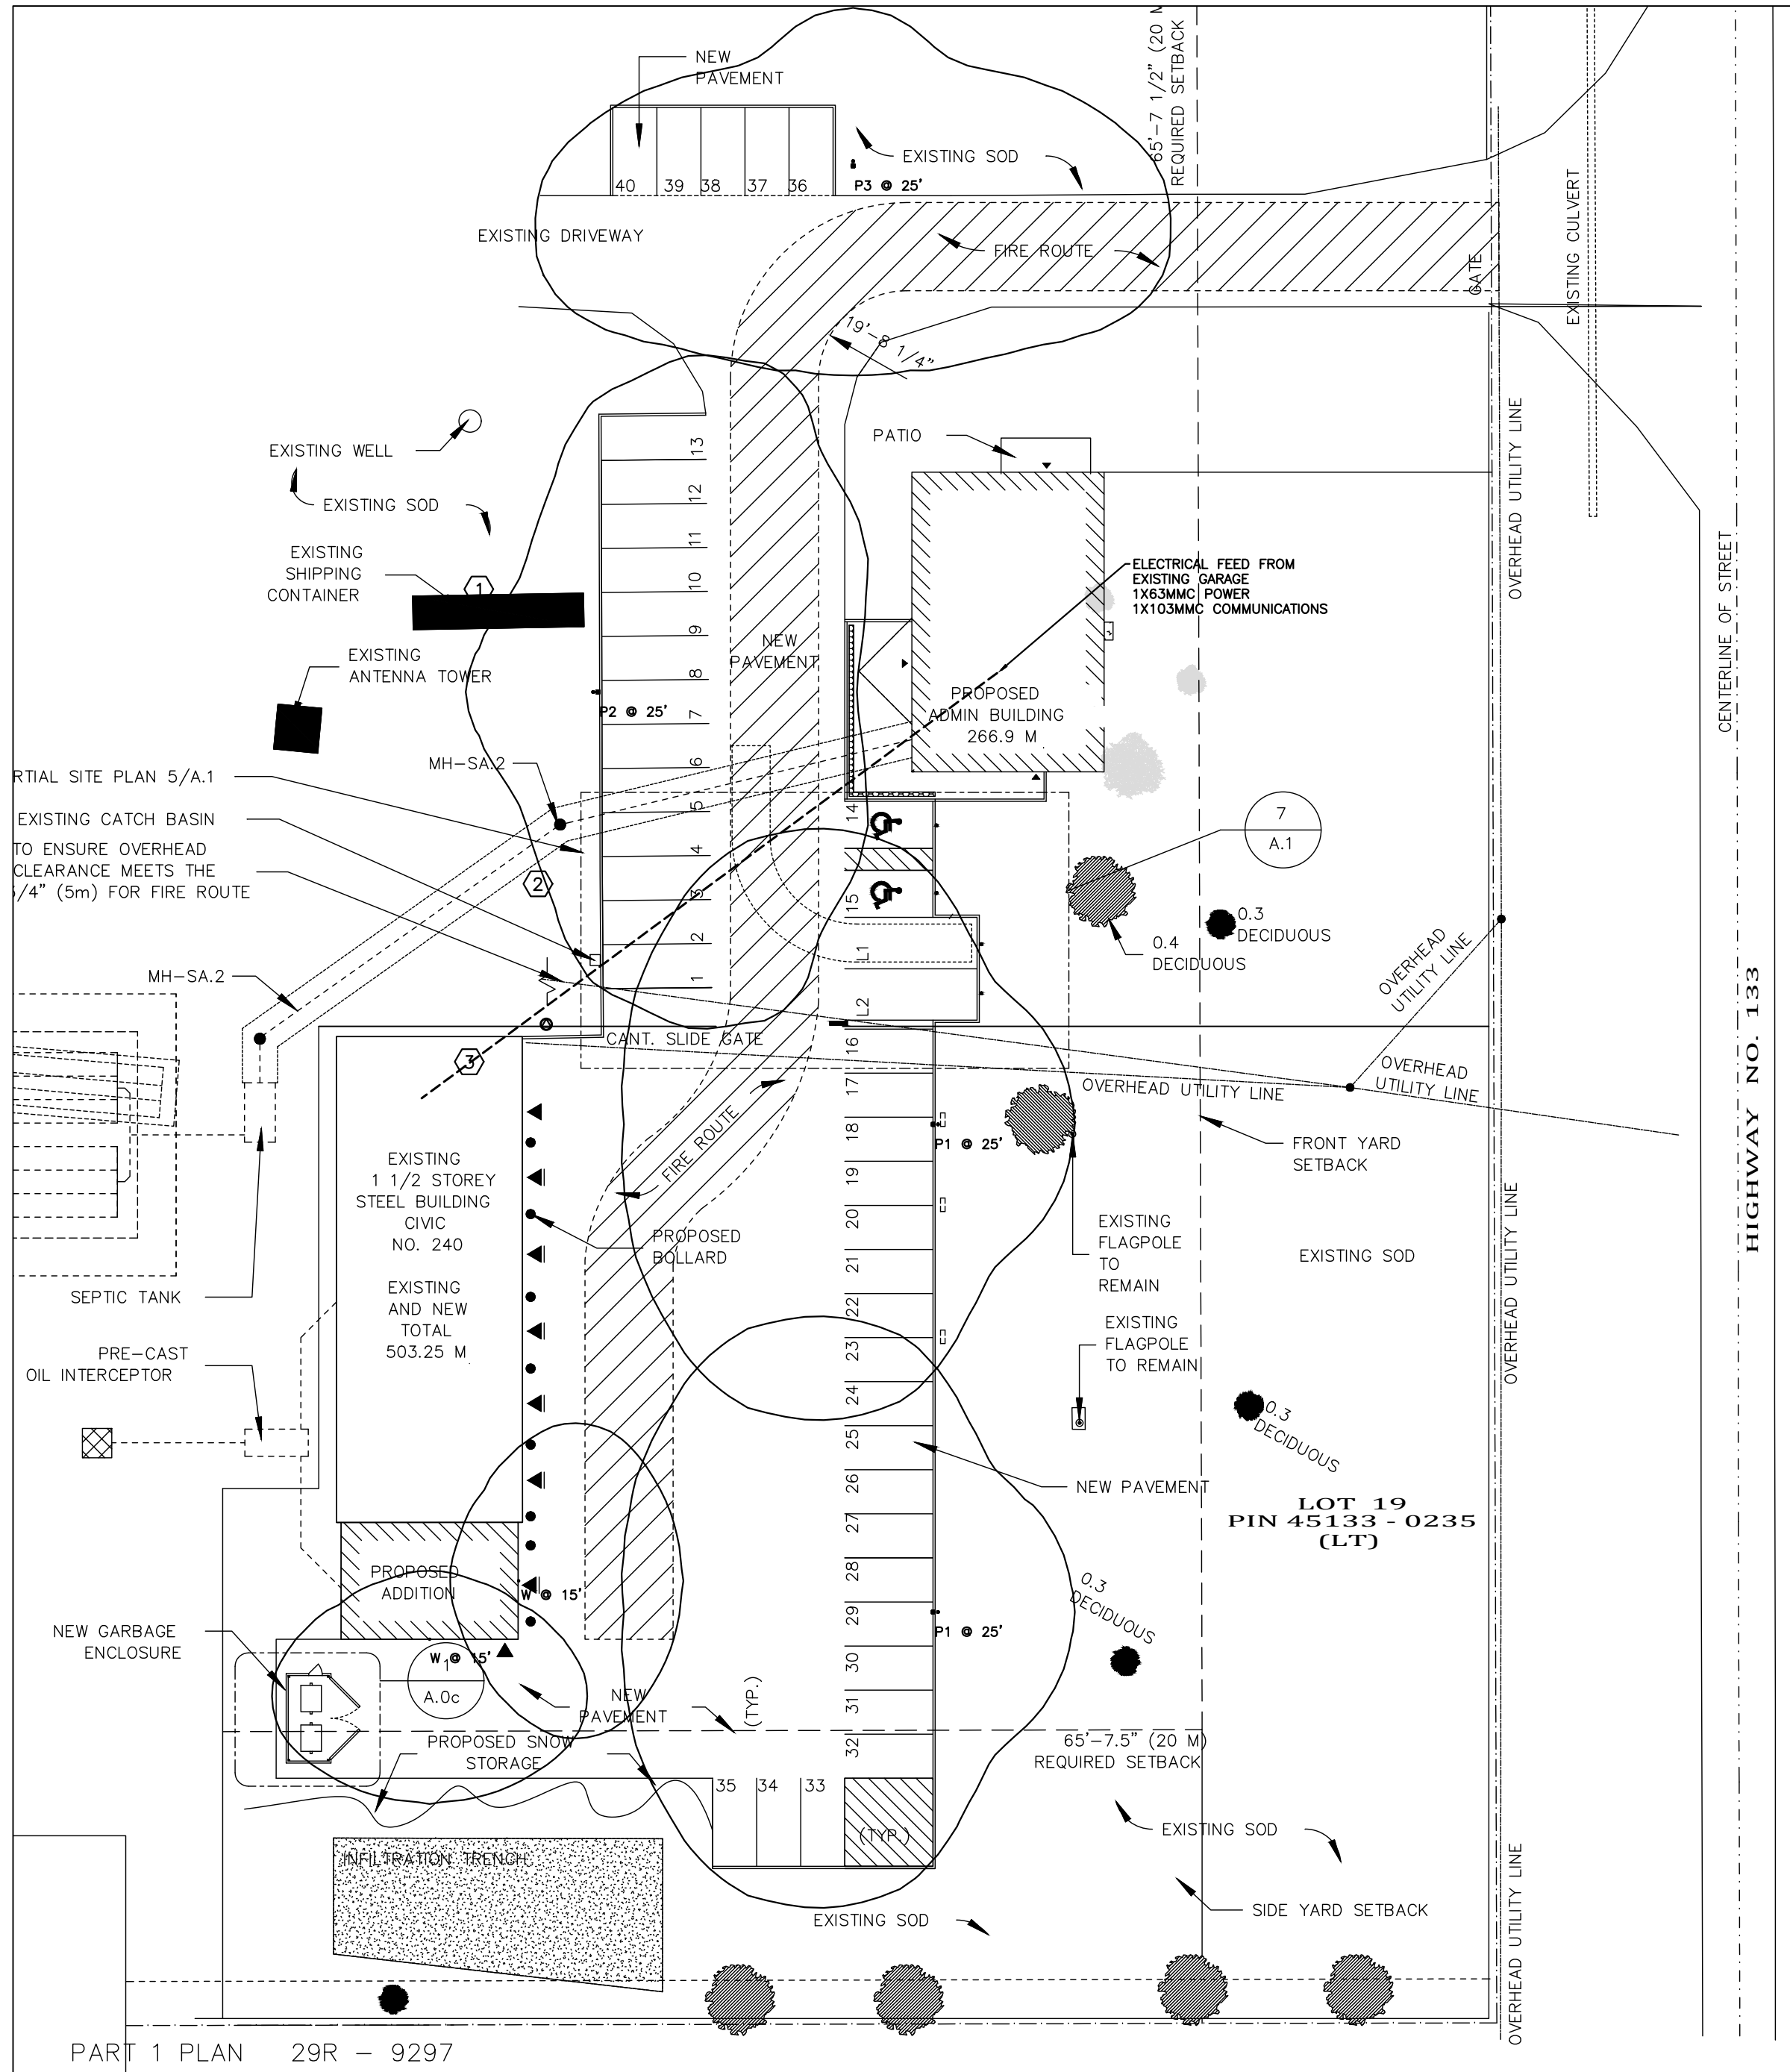

1 ELECTRICAL SITE PLAN
E-4 1/32" = 1' 0"

JRP ENGINEERING
Professional Engineers

110 Didsbury Rd – Unit M090, Kanata, ON, K2T 0C2
Tel: 613-627-2462 Email: Admin@jrpeng.com

An exact copy of all working documents including, without limitations, the original of the present document or plan is kept on file by J.R.P. Engineering. Any modification carried out to this document or plan or to accompanying documents without written authorization by the engineer is prohibited.

Authorized modifications must be signed and sealed by an engineer and this engineer will be completely responsible for these modifications. J.R.P. Engineering is not and will not be responsible for the consequences of these modifications or for modifications carried out without its consent.

4	ISSUED FOR ADDENDUM E2	JULY 14 2026
3	ISSUED FOR PERMIT & TENDER	MAY 29, 2026
2	ISSUED FOR REVIEW	APR. 24, 2026
1	ISSUED FOR PERMIT AND PRICING	FEB. 21, 2025
0	ISSUED FOR REVIEW	APR. 24, 2024
No	DESCRIPTION	DATE
REVISIONS		

client:
BELL+ASSOCIATES
ARCHITECTURE
186 PEMBROKE STREET EAST
PEMBROKE, ON K8A 3J7

project:
MILLHAVEN GARAGE
ADMINISTRATION
BUILDING
240 COUNTY ROAD 4,
BATH, ONTARIO K0H 1G0

drawing title:
ELECTRICAL
SITE PLAN

scale:	AS NOTED	drawn by:	C.M.
designed by:	C.M.	reviewed by:	M.G.
approved by:	M.G.	date:	JULY 2026

project no.: 420-2301-03
drawing no.: E-4
of 5